

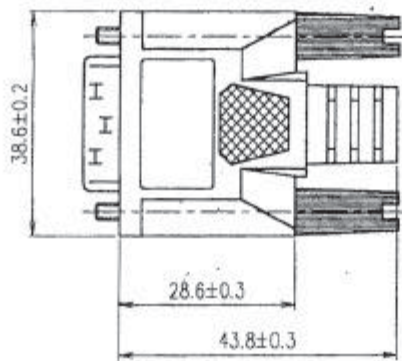


| REV. | NO. | DESCRIPTION | DATE | CHKD | APPR |
|------|-----|-------------|----------|--------------------|--------------------|
| 1.1 | 1 | SECN020018 | 02.03.25 | <i>[Signature]</i> | <i>[Signature]</i> |

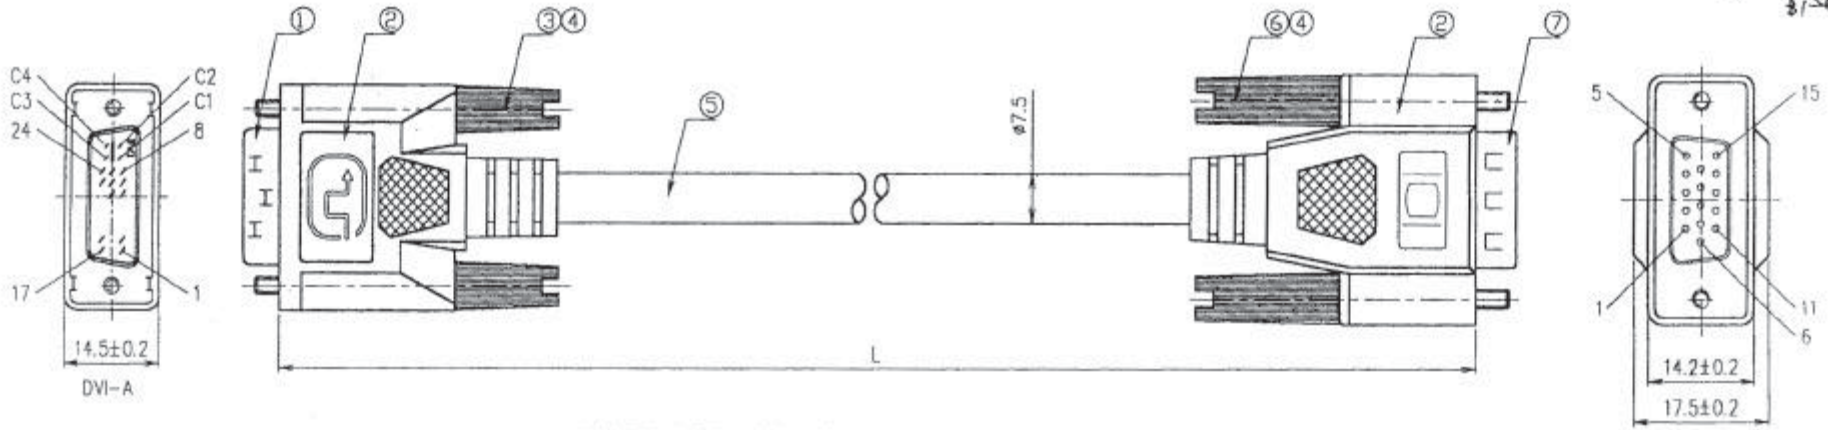

| DVI-A | HD15 | CABLE FUNCTION |
|-----------|--------------|---------------------------|
| PIN 6 | PIN 15 | DDC CLOCK |
| PIN 7 | PIN 12 | DDC DATA |
| PIN 8 | PIN 14 | VERTICAL SYNC |
| PIN 14,16 | PIN 9 | POWER +5V/HOT PLUG DETECT |
| PIN 15 | PIN 5,10 | GROUND(+5V & HV SYNC) |
| C1 | PIN 1 | ANALOG |
| C2 | PIN 2 | ANALOG |
| C3 | PIN 3 | ANALOG |
| C4 | PIN 13 | HORIZONAL SYNC |
| C5 | PIN R6,G7,B8 | ANALOG GROUND |
| SHIELD | SHIELD | GROUND |

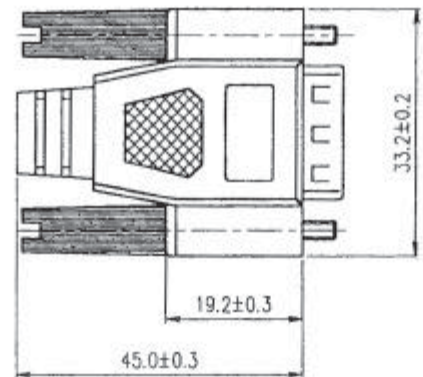

TEST CONDITION:
 1. 100% OPEN/SHORT TEST.
 2. CONTACT RESISTANCE: 2 Ω.
 3. INSULATION RESISTANCE: 50M Ω.
 DC 500V AT 10ms.

| NO. | CUSTOMER | P/N. | PART NO. | L(MM) |
|-----|----------|------|-----------------|---------|
| 2 | 6FT | | 8RDV291801A0330 | 1830±50 |
| 1 | 4FT | | 8RDV291221A0330 | 1220±50 |



| NO. | DESCRIPTION | PART NO. | QTY | TOLERANCE | MATERIAL: | DWG NO.: | DR: | CHKD: | SALES: | APPR: | TITLE: | PART NO.: | UNIT | SCALE | REV. |
|-----|---|----------------------------------|-----|-------------------------|-----------|----------|------|------------|--------|----------|---------------------|-----------------|------|-------|------|
| 7 | HD-SUB 15PIN MALE CONNECTOR:G/F,BLACK IN COLOR,NICKEL PLATED SHELL. | 7CHDS1510200010 (GH15-MSN101-0K) | 1 | SELECT | | SDC-9004 | Jean | David teat | | Jeff yeh | DVI 17P/HD15P CABLE | E08-AM-HD15M-XX | mm | 1/1 | 1 |
| 6 | THUMB SCREW: 4-40/TS040*395TNOPOB | WE020047 | 2 | 0.000 +/- 0.05 0.1 0.15 | | | | | | | | | | | |
| 5 | UL20276 3C*UL1354+1P*30#+5C*30#+AL+D+B,OD: 7.5, BLACK | WF040063*0122 | | 0.00 +/- 0.1 0.15 0.25 | | | | | | | | | | | |
| 4 | PVC MOLDING HOOD, BLACK | WZ000056* | | 0.0 +/- 0.15 0.3 0.5 | | | | | | | | | | | |
| 3 | THUMB SCREW: AF40*323TNPL35A | WE020083* | 2 | 0.0 +/- 0.25 0.5 1.0 | | | | | | | | | | | |
| 2 | PVC MOLDING WITH METAL CAN SHIELDED, BLACK | WZ000015 | | ANGLE +/- | | | | | | | | | | | |
| 1 | DVI-A MALE CONNECTOR: G/F15U, BLACK INSULATOR, NICKEL PLATED SHELL. | 7CDVS2910200141 | 1 | | | | | | | | | | | | |